
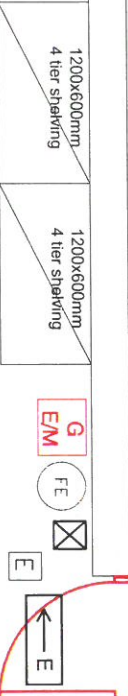


The Contractor is responsible for checking dimensions, tolerances and references. Where an item is covered by drawings to different scales the larger scale drawing is to be worked to. All fit out manufacturers to take direct measurements on site before commencing work. Architect will not be held responsible for any deficiencies in the survey and any furniture mis-fits

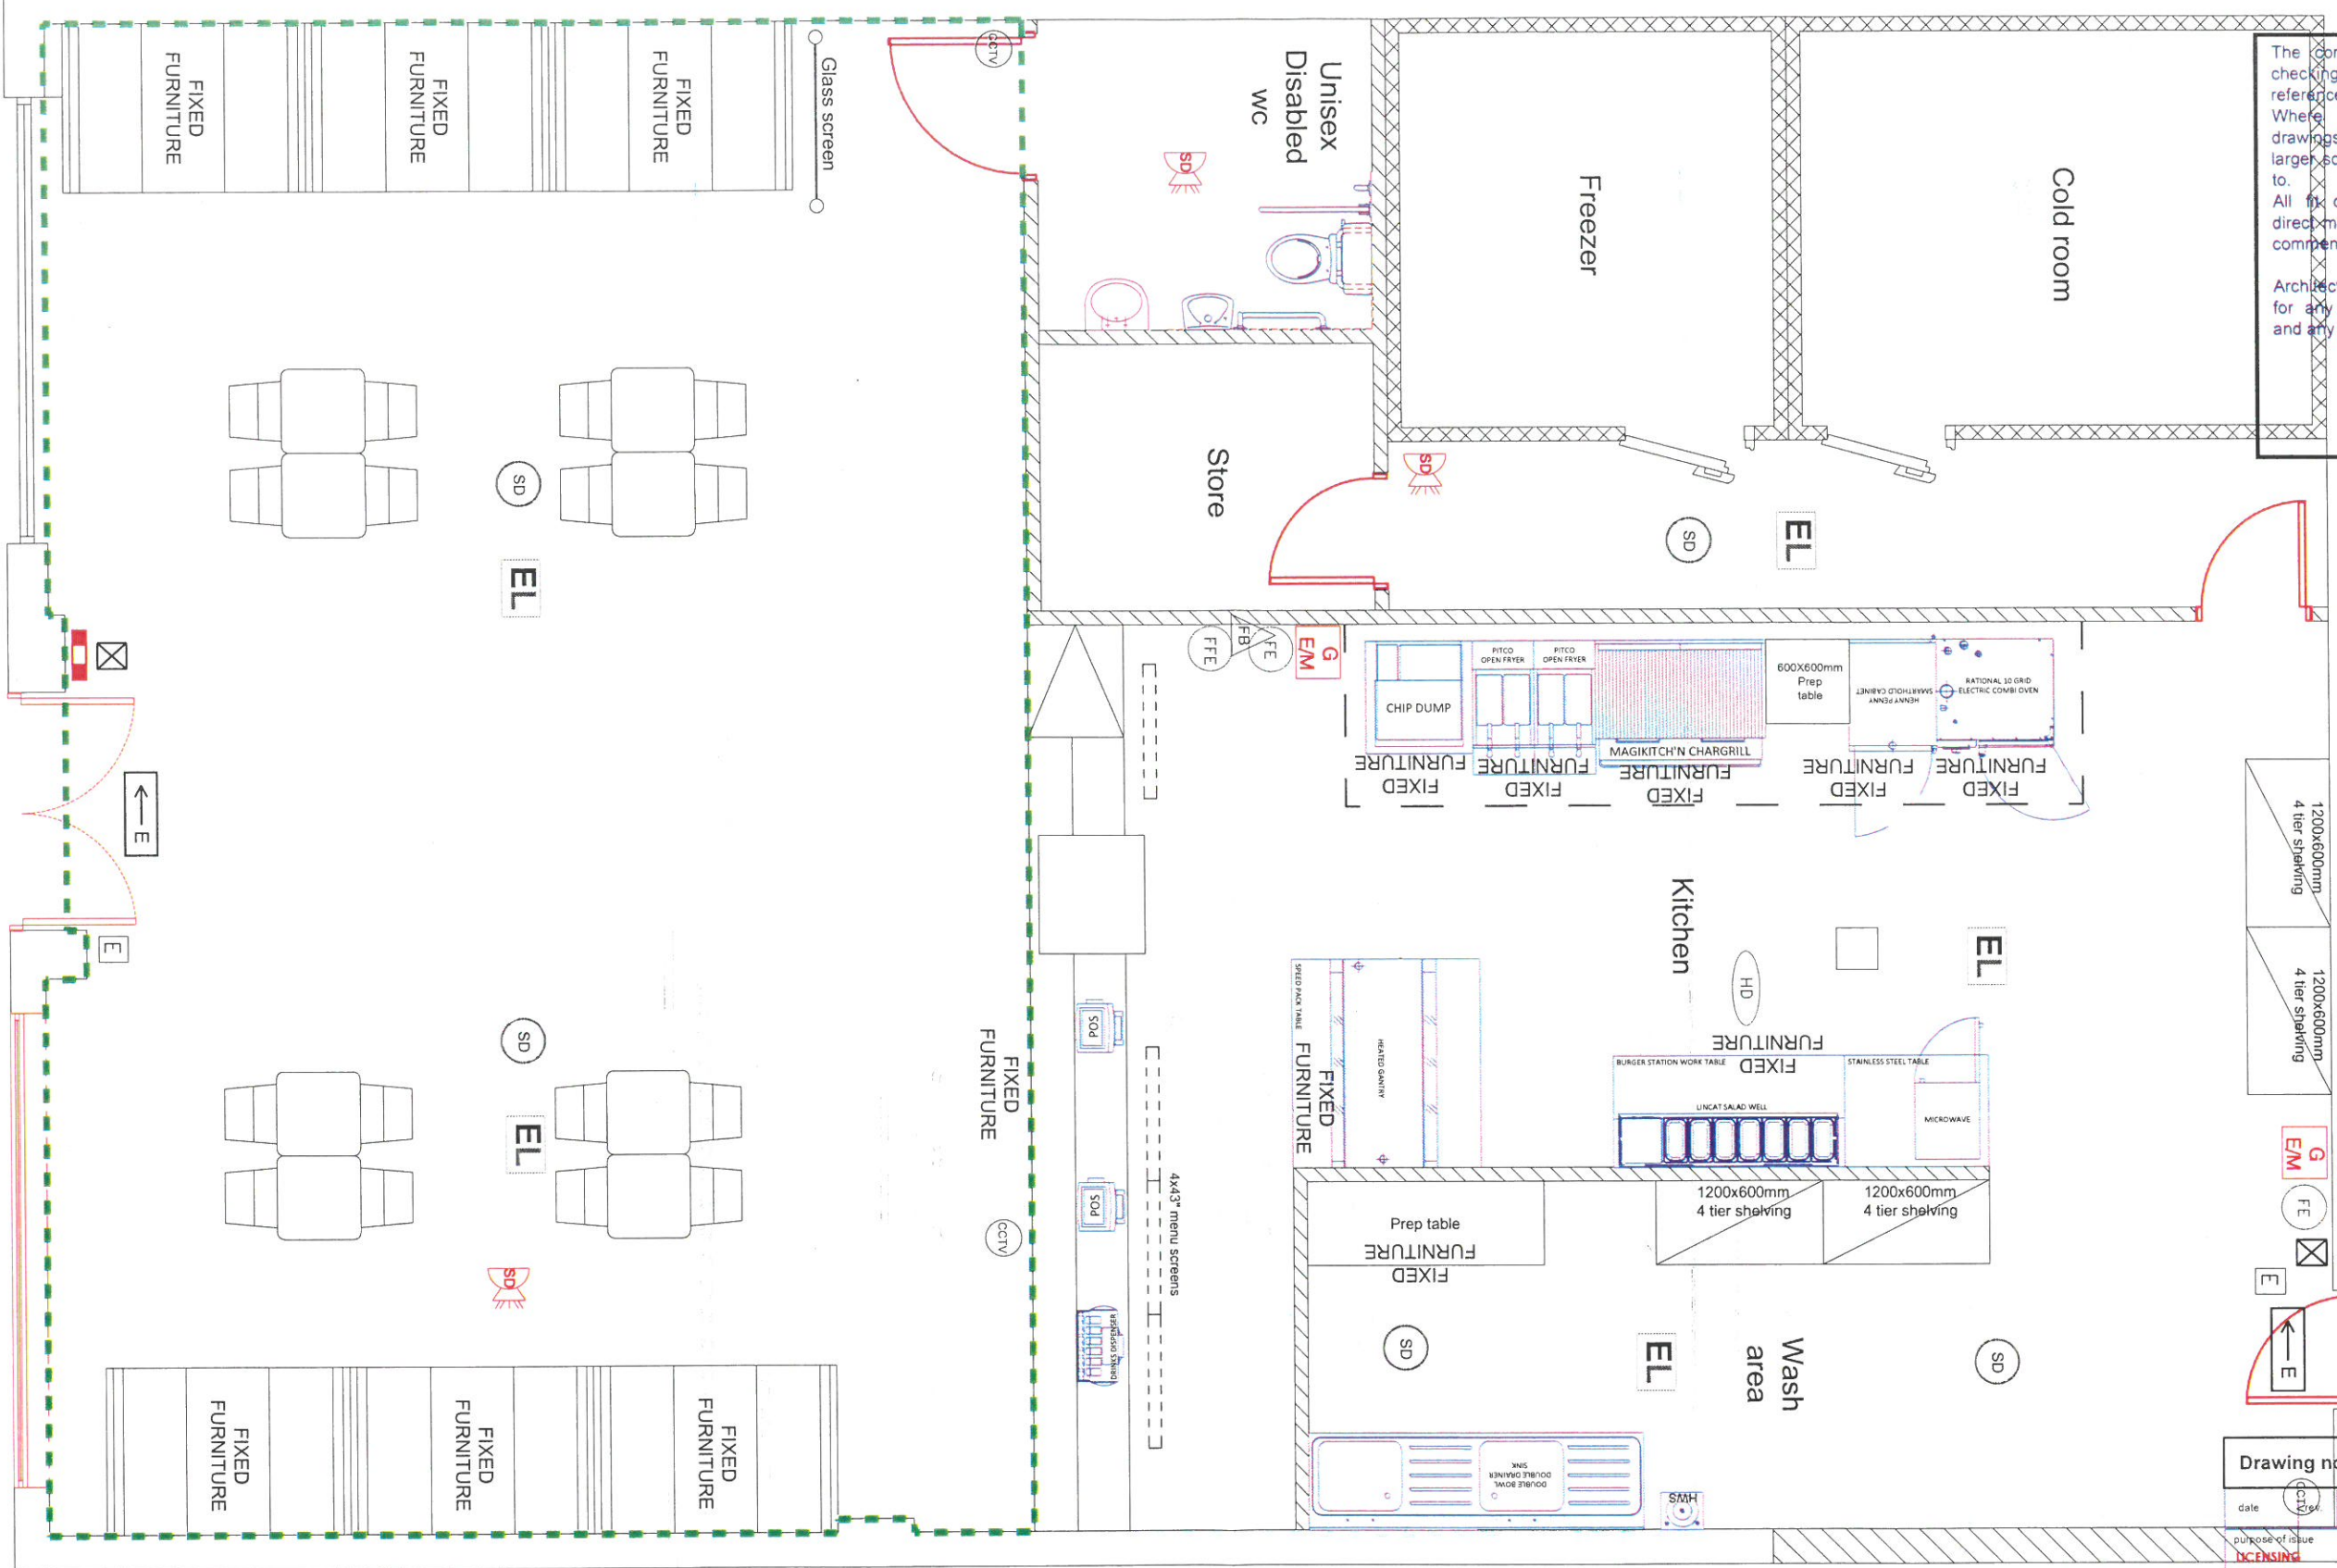

Drawing no. **2.0**
 date (CDD) revision/author/checker
 purpose of issue
ISSUING

Project
498-500 Pleck Road, Walsall

Drawing
GROUND FLOOR PLAN

Job no.
2017-0131

Drawn **GS** checked
 Scale **1:50 @A3** Date **21-06-2017**



- FIRE ALARM SOUNDER BEACON
- HIGH TEMPERATURE HEAT DETECTOR
- SMOKE DETECTOR
- EMERGENCY LIGHTING
- EMERGENCY EXIT DIRECTION SIGN ABOVE DOOR
- FIRE EXIT SIGN
- BREAK GLASS
- ALARM CONTROL PANEL
- EMERGENCY GAS SWITCH OFF
- FIRE EXTINGUISHER
- FOAM FIRE EXTINGUISHER
- FIRE BLANKET
- CCTV QUANTITY AND LOCATIONS TO BE CONFIRMED WITH CLIENT
- Proposed late night refreshment license activity

Proposed ground floor
 Internal Layout

108 838
 23/06/2017
 11:07 AM, 13/06/17
 07:08 18/06/17